


PRODUCED BY AN AUTODESK EDUCATIONAL PRODUCT

PRODUCED BY AN AUTODESK EDUCATIONAL PRODUCT

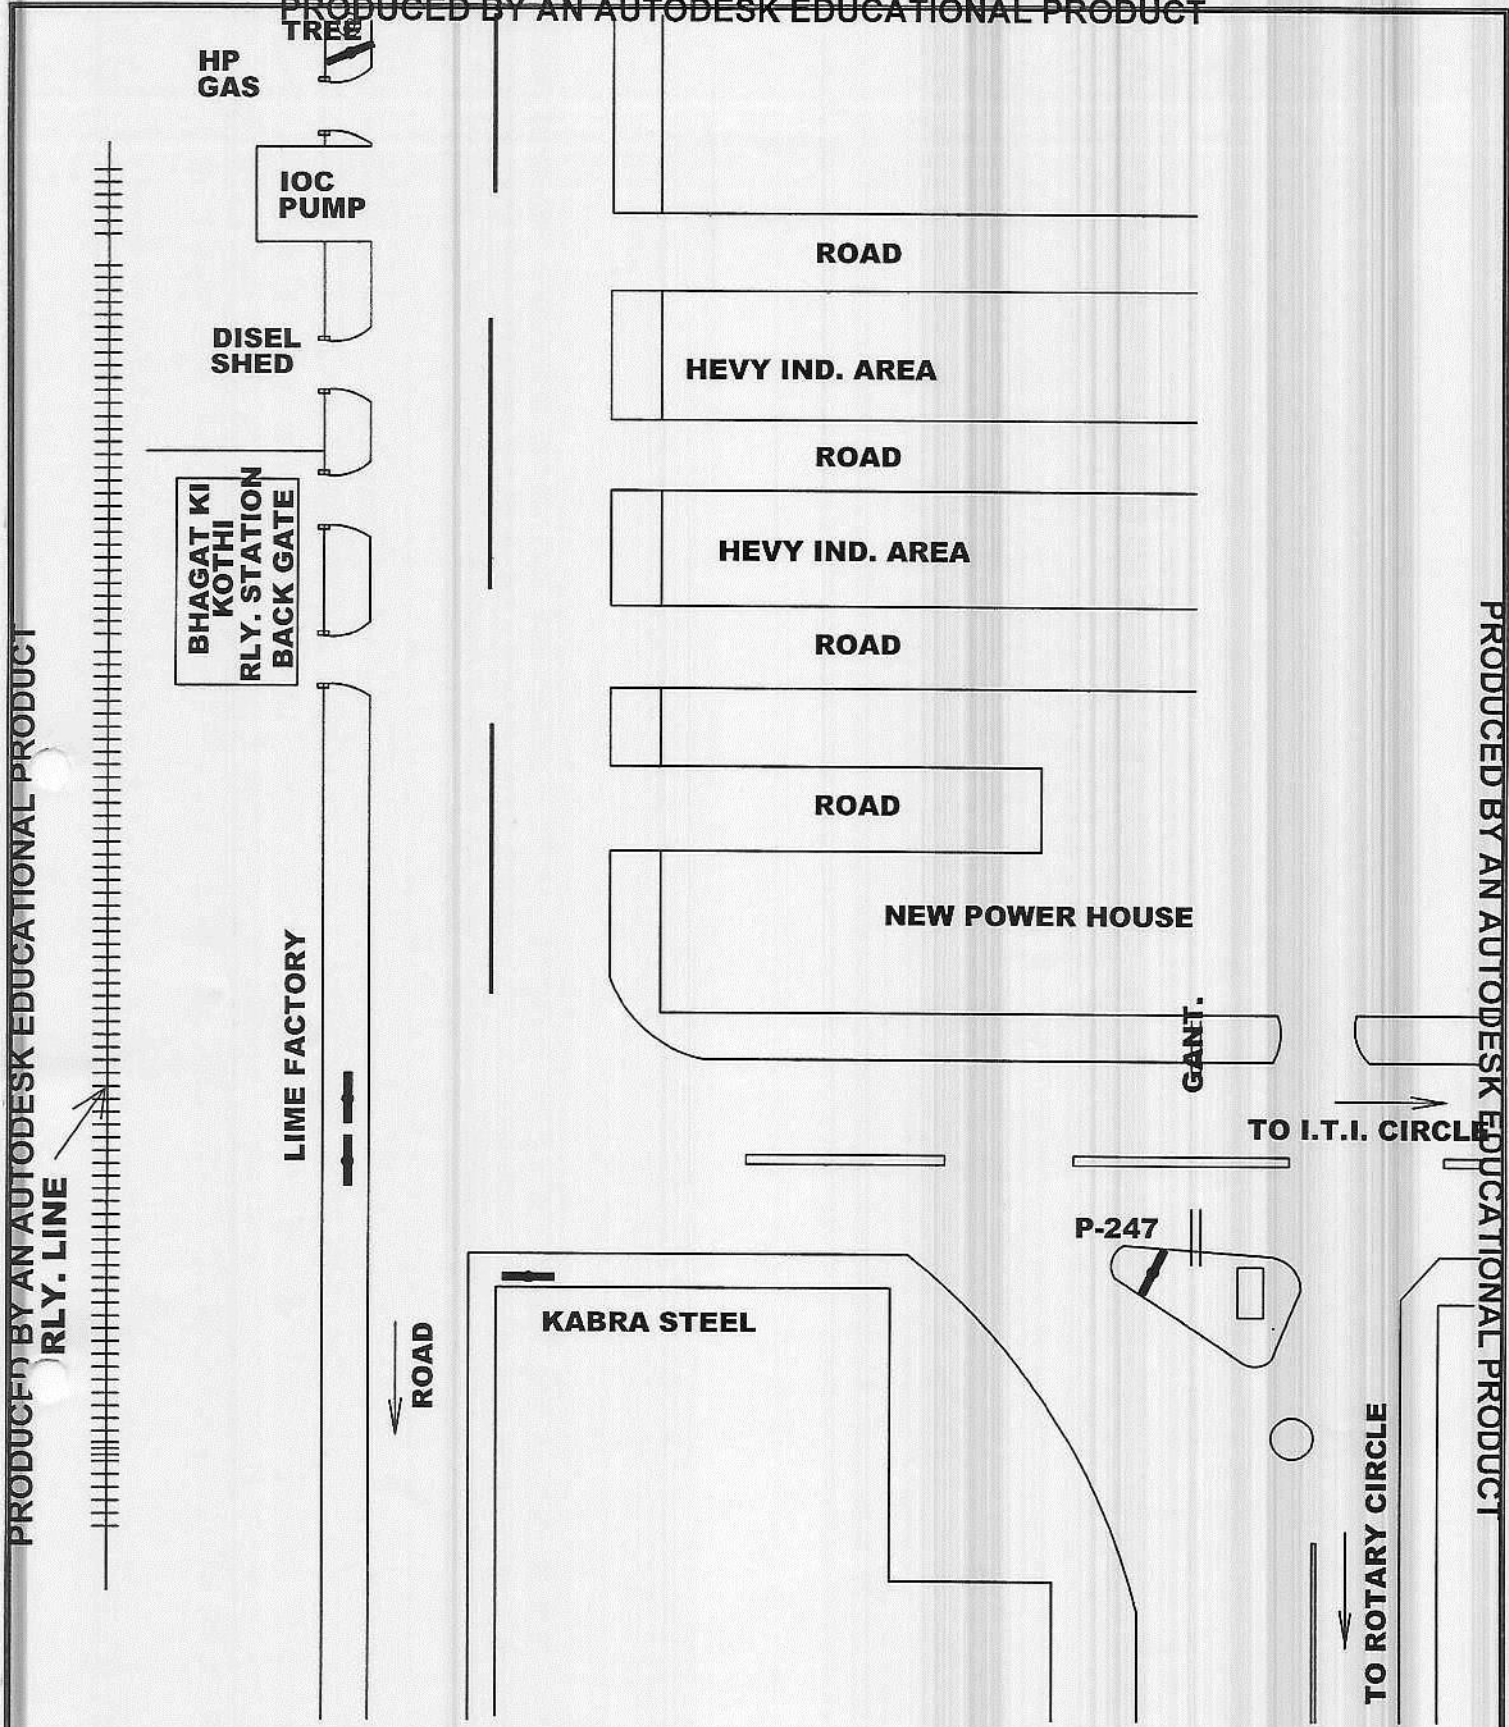

MUNICIPAL CORPORATION, JODHPUR.

SITE PLAN OF UNI POLE NO. 247 AT NEW POWER HOUSE TO AIIMS HOSPITAL ROAD, OPP. NEW POWER HOUSE, JODHPUR .

YEAR : 2019 - 20	NAME :	DRAWING NO . 302
SCALE : NTS	APPROVED BY:
WARD NO.	CITY ZONE